


# Site Location Plan

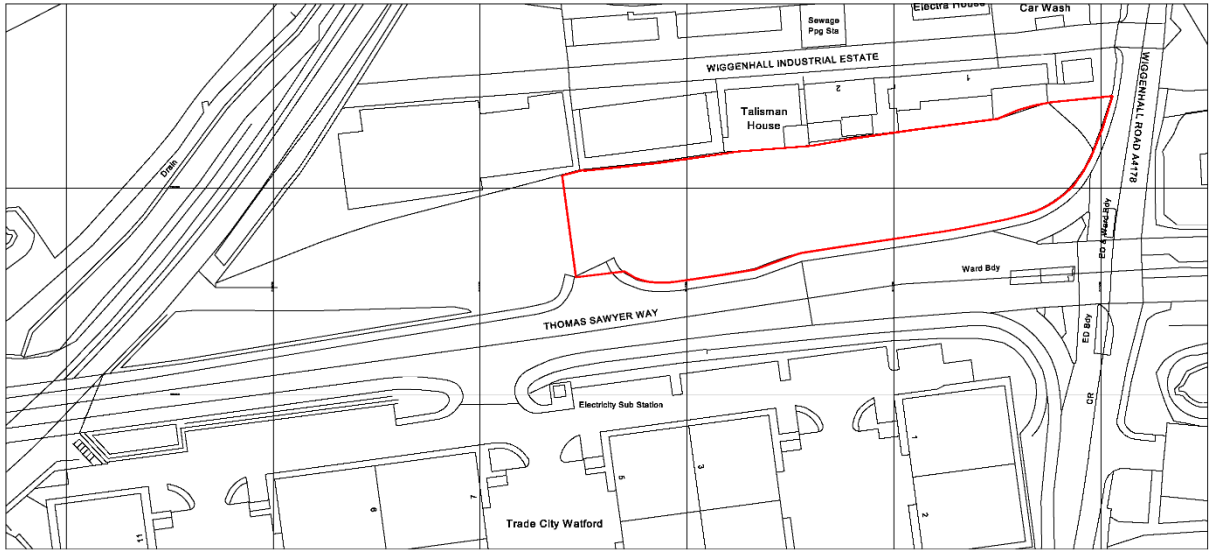


Ordnance Survey, (c) Crown Copyright 2021. All rights reserved. Licence number 100022432


# Proposed Site Plan



# All Elevations

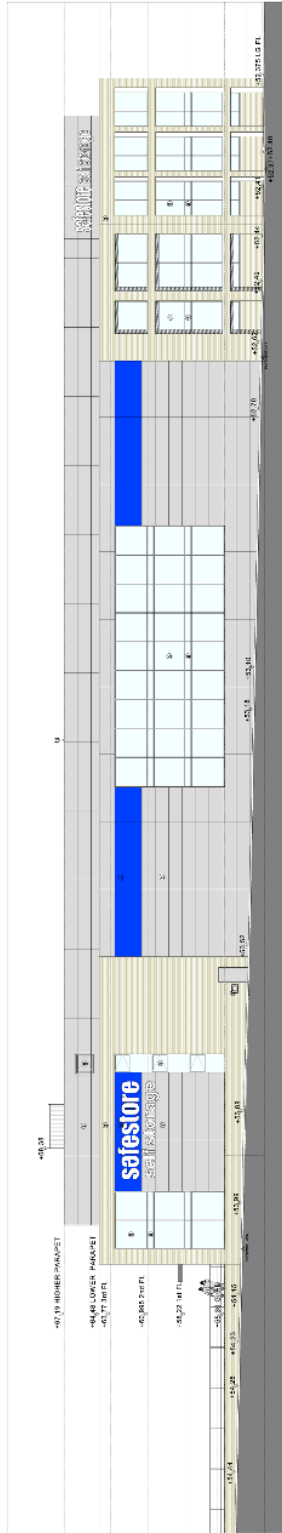

ELEVATION 1 - SOUTH ELEVATION

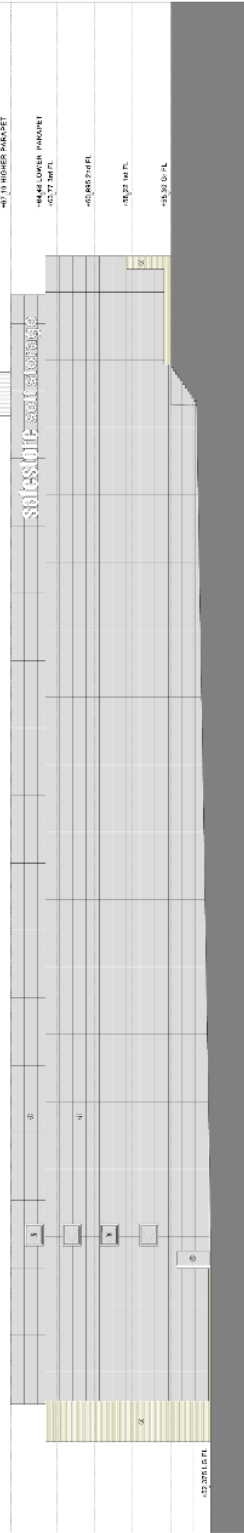

ELEVATION 3 - NORTH ELEVATION



ELEVATION 2 - EAST ELEVATION

ELEVATION 4 - WEST ELEVATION



- 1. SCALE: 1/8" = 1'-0"
- 2. SEE ARCHITECTURAL DRAWINGS FOR DETAILS.
- 3. SEE MECHANICAL DRAWINGS FOR DETAILS.
- 4. SEE ELECTRICAL DRAWINGS FOR DETAILS.
- 5. SEE PLUMBING DRAWINGS FOR DETAILS.
- 6. SEE STRUCTURAL DRAWINGS FOR DETAILS.
- 7. SEE CIVIL DRAWINGS FOR DETAILS.
- 8. SEE LANDSCAPE ARCHITECTURE DRAWINGS FOR DETAILS.
- 9. SEE INTERIOR ARCHITECTURE DRAWINGS FOR DETAILS.
- 10. SEE EXTERIOR ARCHITECTURE DRAWINGS FOR DETAILS.
- 11. SEE FINISH SCHEDULE FOR DETAILS.
- 12. SEE MATERIAL SCHEDULE FOR DETAILS.
- 13. SEE LIGHTING SCHEDULE FOR DETAILS.
- 14. SEE SOUND ATTENUATION SCHEDULE FOR DETAILS.
- 15. SEE VENTILATION SCHEDULE FOR DETAILS.
- 16. SEE ENERGY EFFICIENCY SCHEDULE FOR DETAILS.
- 17. SEE SUSTAINABILITY SCHEDULE FOR DETAILS.
- 18. SEE ACCESSIBILITY SCHEDULE FOR DETAILS.
- 19. SEE SECURITY SCHEDULE FOR DETAILS.
- 20. SEE OTHER SCHEDULES FOR DETAILS.

**TEW AND SMITH**  
 ARCHITECTS AND ENGINEERS  
 1000 W. 10TH AVENUE, SUITE 1000  
 DENVER, CO 80202  
 TEL: 303.733.1111  
 FAX: 303.733.1112  
 WWW.TEWANDSMITH.COM


PROJECT:  
 SAFEFIRE  
 1400 W. 10TH AVENUE  
 DENVER, CO 80202

DRAWING NO.: 2024-001  
 DATE: 10/20/24  
 PROJECT ELEVATIONS

DRAWN BY: J. SMITH  
 CHECKED BY: T. ANDERSON  
 PROJECT MANAGER: J. SMITH



CGI looking west along Thomas Sawyer Way at junction of Wigenhall Road

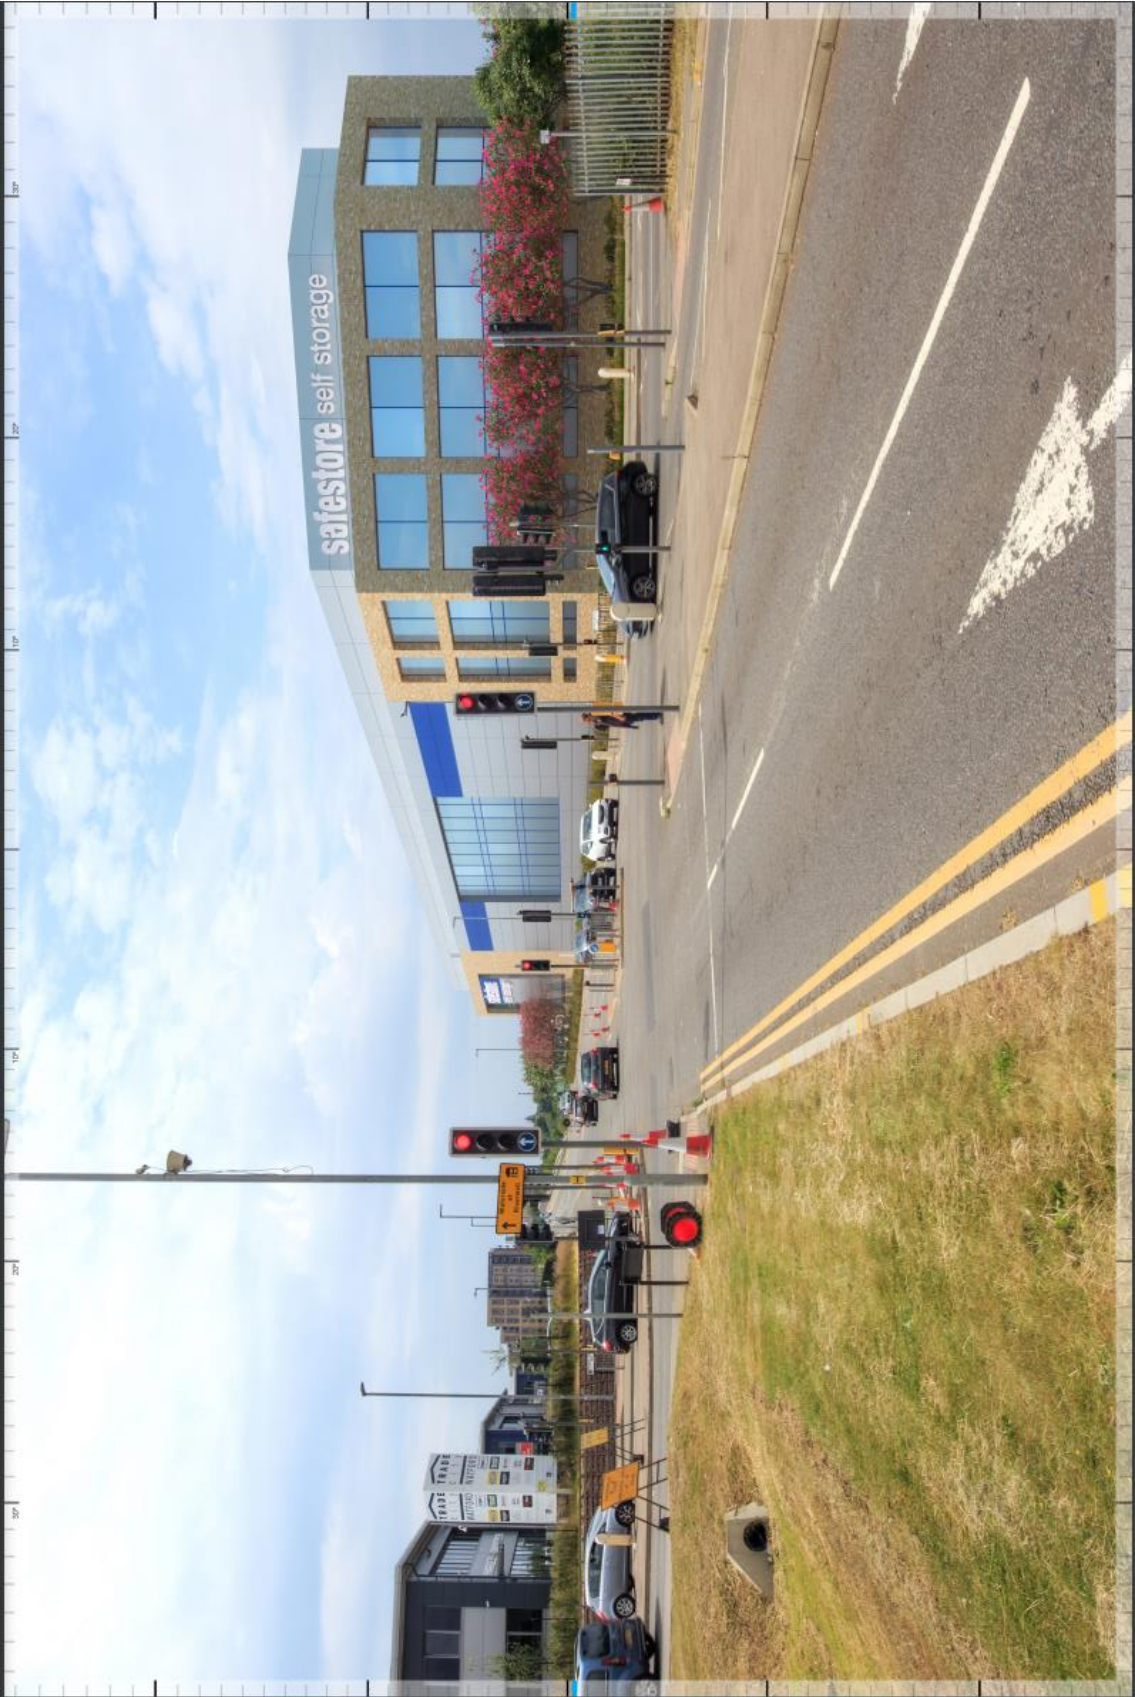

CGI looking east along Thomas Sawyer Way

